



Village of Hinsdale
19 E. Chicago Avenue
Hinsdale, IL 60521-3489
(630)789-7000
Village Website: www.villageofhinsdale.org

PUBLIC SERVICES UTILITY PERMIT APPLICATION

Date of Application: 9/25/20 Permit No: Comcast 0032 Permit Expiration Date: 10-31-20

Utility Company Information:

Company Name: Comcast Cable
Address: 5N301 Medinah Rd
City, State, Zip: Addison, IL 60101
Contact Person: Adriana Candia
Phone Number: 224.229.6594
Email Address: adriana_candia@comcast.com
Cell Number: 224.343.0938
Project/Work Order Number: PTC-JB414106NS

Contractor Information:

Company Name: PirTano Construction
Address: 1766 Armitage Ct
City, State, Zip: Addison, IL 60101
Contact Person: John Moul
Phone Number: 630.776.3387
Email Address: john.moul@pirtano.com
Cell Number: 630.776.3387

PROJECT LOCATION: E 7th Street and S County Line Road

Description of work covered under this permit: Install new CATV fiber optic cable between an existing utility pole located on S County Line Road and an existing utility pole located on E 7th Street as shown on the drawing. All CATV cable will be installed underground by directional boring. Permit to include road bore underneath S County Line Road.

Start Date: 10-6-20 Completion Date: 10-7-20

Site Plan/Details/Specifications (3 sets) included with application? YES NO
Certificate of Insurance included with application? YES NO

Type of Utility: ComEd Nicor Comcast Water Sewer
 Communications: Fiber Optic Wireless Other: _____

Applicant Information:

Print Name: Olivia Carlin Phone Number: 630.522.3024
Company: ESPO Engineering Email Address: ocarlin@espocorp.com
Signature: *Olivia Carlin* Date: 9-25-20

ALL CONSTRUCTION SHALL BE DONE IN ACCORDANCE WITH THE LATEST EDITION IN EFFECT ON THE DATE OF PERMIT APPLICATION OF THE FOLLOWING: STANDARD SPECIFICATIONS FOR ROAD AND BRIDGE CONSTRUCTION & SUPPLEMENTAL SPECIFICATIONS AND RECURRING SPECIAL PROVISIONS BY THE ILLINOIS DEPARTMENT OF TRANSPORTATION, ILLINOIS MANUAL ON UNIFORM TRAFFIC CONTROL DEVICES FOR STREETS AND HIGHWAYS, STANDARD SPECIFICATIONS FOR WATER AND SEWER MAIN CONSTRUCTION IN ILLINOIS, AND THE VILLAGE OF HINSDALE SUBDIVISION ORDINANCE AND ENGINEERING STANDARDS.

Village Use Only


Permit Approved: YES NO

Conditions for Approval/Reasons for Denial: RESTORE ALL DISTURBED AREAS WITHIN 14 DAYS OF CABLE INSTALLATION.

Approved By: *A. Diaz* Date: 9/25/20

VILLAGE OF HINSDALE PERMIT DRAWING E 7TH ST & S COUNTY LINE RD HINSDALE, IL

SITE MAP

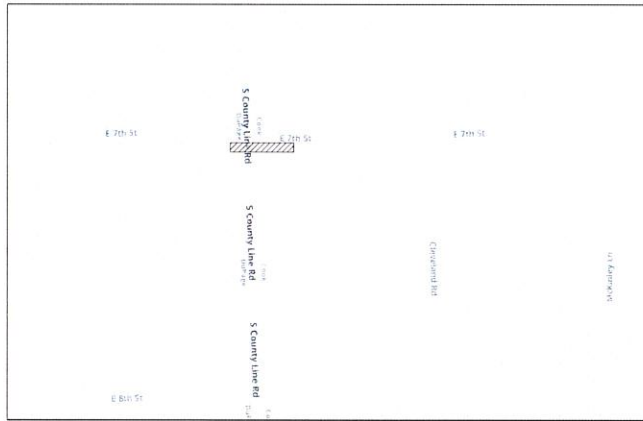

NOT TO SCALE

LEGEND

SYMBOLS	
⊗ JOINT POLE	⊗ TRANSFORMER POLE
× POWER POLE	○ TELEPHONE POLE
● CATV POLE	⊗ 6X6 SERVICE RISER
⊞ CATV VAULT	— GUY AND ANCHOR
⊞ FELCO VAULT	⊞ TRAFFIC CONTROL VAULT
⊞ CATV PED	⊞ UNMARKED VAULT
⊞ CATV LOCKBOX	⊞ SERVICE PIT
⊞ FIRE HYDRANT	⊞ CATV POWER SUPPLY
⊞ CATCH BASIN	⊞ AIR CONDITIONER
⊞ SEWER DRAIN	⊞ GENERATOR
⊞ CULVERT PIPE	⊞ WATER METER
⊞ WATER VALVE	⊞ UNMARKED MANHOLES
⊞ GAS VALVE	⊞ CATV MANHOLE
⊞ TELCO PED	⊞ ELECTRIC MANHOLE
⊞ TRANSFORMER	⊞ TRAFFIC MANHOLE
⊞ MAIL BOX	⊞ TELEPHONE MANHOLE
⊞ FIBER MARKER	⊞ FIBER DRAIN
⊞ GAS METER	⊞ SEWER MANHOLE
⊞ ROAD SIGN	⊞ WATER MANHOLE
⊞ R R X'ING GATE	⊞ FOUR DIRECTIONAL GAS MARKER
⊞ TREE	⊞ RIGHT-OF-WAY MARKER
⊞ SLUSH	⊞ SIGN
⊞ STREET LIGHT	⊞ TRAFFIC SIGNAL LIGHT
⊞ ELECTRIC VAULT/PEDMETER	



THE INFORMATION IN THIS DRAWING FILE IS PROPRIETARY AND CONFIDENTIAL AND MAY NOT BE REPRODUCED OR TRANSMITTED BY ANY MEANS OF CONVEYANCE WITHOUT WRITTEN PERMISSION FROM COMCAST

PIRTANO CONSTR. CO, INC
1800 W. 111th St. Mokena, IL 60450

JOB NO: **PTC-18414106NS**
PROJECT TITLE: **COMCAST U-GROUND COMMUNICATION CABLE**
NODE SEGMENT

LOCATION: **E 7TH ST & S COUNTY LINE RD HINSDALE, IL**

DRAWING NO: **PTC-18414106NS**

SHEET NO: **1 OF 2**

ESPO ENGINEERING
165 W. OAK ST. WILLOW SPRING, IL 60097
815.789.2528
www.espoeng.com

ENG NUMBER **PTC-20-2528**

DRAWN BY: **SEG** DATE: **09/23/2020**

ISSUED FOR PERMITTING

SCALE: **1"=50'**

REVISIONS

DATE	BY	DESCRIPTION


COOK COUNTY
LYONS TWP 138N R72E
N 1/4 OF S 1/4 OF SEC 7

DUPAGE COUNTY
DOWNERS GROVE TWP 138N R11E
N E 1/4 OF S E 1/4 OF SEC 12

INDEX OF SHEETS
1. COVER SHEET
2. PLAN SHEET

PROJECT DESCRIPTION
PROPOSED INSTALLATION OF UNDERGROUND CABLE - 2" HDPE w/48CT F.O. CABLE @ 36" MIN. DEPTH BY DIRECTIONAL BORING

PROJECT DETAIL
CABLE LENGTH (ft): 113
COMCAST COORD: SHARIF KHAN

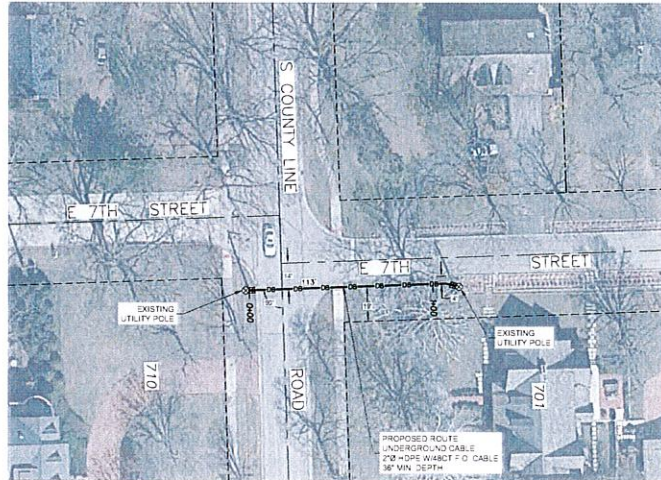

LEGEND

SYMBOLS	
⊗	JOINT POLE
⊗	TRANSFORMER POLE
x	POWER POLE
○	TELEPHONE POLE
●	CATV POLE
⊗	EXF SERVICE RIBER
⊞	CATV VAULT
⊞	GUY AND ANCHOR
⊞	TELECOMM VAULT
⊞	TRAFFIC CONTROL VAULT
⊞	CATV PED
⊞	UNMARKED VAULT
▲	CATV LOCKBOX
▲	SCORE SPACE HIT
▲	FIRE HYDRANT
▲	CATV POWER SUPPLY
▲	CATCH BASIN
▲	AIR CONDITIONER
▲	SEWER DRAIN
▲	GENERATOR
▲	CULVERT PIPE
▲	WATER METER
▲	WATER VALVE
▲	UNMARKED MAN-HOLES
▲	GAS VALVE
▲	CATV MANHOLE
▲	TELECOMM MANHOLE
▲	TRANSFORMER
▲	TRAFFIC MANHOLE
▲	MANHOLE
▲	TELEPHONE MANHOLE
▲	SEWER MANHOLE
▲	GAS METER
▲	WATER MANHOLE
▲	ROAD SIGN
▲	R/R KING GATE
▲	GAS MARKER
▲	WATER MARKER
▲	STREET LIGHT
▲	TRAFFIC SIGNAL LIGHT
▲	ELECTRIC VAULTED METER



THE INFORMATION IN THIS DRAWING FILE IS PROPRIETARY AND CONFIDENTIAL AND MAY NOT BE REPRODUCED OR TRANSMITTED BY ANY MEANS OR CONVEYED WITHOUT WRITTEN PERMISSION FROM COMCAST

PIRTANO CONSTR. CO, INC
186 STATE ST. SUITE 200 CHICAGO, IL 60601

JOB NO. **PTC-18414106NS**
PROJECT TITLE **COMCAST U-GROUND COMMUNICATION CABLE**
NODE SEGMENT
LOCATION **E 7TH ST & S COUNTY LINE RD MINDSDALE, IL**
DRAWING NO. **PTC-18414106NS**
SHEET NO. **2 OF 2**

ESPO ENGINEERING
13617 W. 151ST ST. SUITE 100
MAYWOOD, IL 60153
TEL: 708.525.1100
WWW.ESPOENGINEERING.COM

ENG NUMBER **PTC-20-2528**
DRAWN BY: **EGC** DATE: **08/13/2020**

ISSUED FOR PERMITTING
SCALE: **1"=50'**

REVISIONS

DATE	BY	DESCRIPTION

