



Village of Hinsdale
19 E. Chicago Avenue
Hinsdale, IL 60521-3489
(630)789-7000

Village Website: www.villageofhinsdale.org

PUBLIC SERVICES UTILITY PERMIT APPLICATION

Date of Application: 11/6/20 Permit No: ComCast 0034 Permit Expiration Date: 12-31-2020

Utility Company Information:

Company Name: Comcast Cable
Address: 880 Donata Rd
City, State, Zip: Lake Zurich, IL 60047
Contact Person: Phillip Jones
Phone Number: 224.229.4455
Email Address: phillip_jones@comcast.com
Cell Number: 630.688.7432
Project/Work Order Number: PTC-JB496762RP

Contractor Information:

Company Name: AXS Points
Address: 1901 Industrial Dr
City, State, Zip: Libertyville, IL 60048
Contact Person: Dan Fisher
Phone Number: 847.752.8214
Email Address: dfisher@axspoints.net
Cell Number: 847.752.8214

PROJECT LOCATION: Woodland Avenue at 810 Taft Road

Description of work covered under this permit: Install replacement CATV coax cable between an existing utility pole located on Woodland Avenue and an existing utility pole located in rear of 810 Taft Road as shown on the drawing. All CATV cable will be installed underground by directional boring in the same location as existing damaged cable. Permit to include road bore underneath Woodland Avenue.

Start Date: 11/18/20

Completion Date: 11/18/20

Site Plan/Details/Specifications (3 sets) included with application? ☒ YES ☐ NO
Certificate of Insurance included with application? ☒ YES ☐ NO

Type of Utility: ☐ ComEd ☐ Nicor ☒ Comcast ☐ Water ☐ Sewer
☐ Communications: ☐ Fiber Optic ☐ Wireless ☐ Other: _____

Applicant Information:

Print Name: Olivia Carlin Phone Number: 630.522.3024
Company: ESPO Engineering Email Address: ocarlin@espocorp.com
Signature: Olivia Carlin Date: 11/6/20

ALL CONSTRUCTION SHALL BE DONE IN ACCORDANCE WITH THE LATEST EDITION IN EFFECT ON THE DATE OF PERMIT APPLICATION OF THE FOLLOWING: STANDARD SPECIFICATIONS FOR ROAD AND BRIDGE CONSTRUCTION & SUPPLEMENTAL SPECIFICATIONS AND RECURRING SPECIAL PROVISIONS BY THE ILLINOIS DEPARTMENT OF TRANSPORTATION, ILLINOIS MANUAL ON UNIFORM TRAFFIC CONTROL DEVICES FOR STREETS AND HIGHWAYS, STANDARD SPECIFICATIONS FOR WATER AND SEWER MAIN CONSTRUCTION IN ILLINOIS, AND THE VILLAGE OF HINSDALE SUBDIVISION ORDINANCE AND ENGINEERING STANDARDS.

Village Use Only


Permit Approved: ☒ YES ☐ NO

Conditions for Approval/Reasons for Denial: RESTORE ALL DISTURBED AREAS WITHIN 14 DAYS OF CABLE INSTALLATION.

Approved By: J. A. Diaz Date: 11/6/20

VILLAGE OF HINSDALE PERMIT DRAWING 810 TAFT RD HINSDALE, IL

SITE MAP

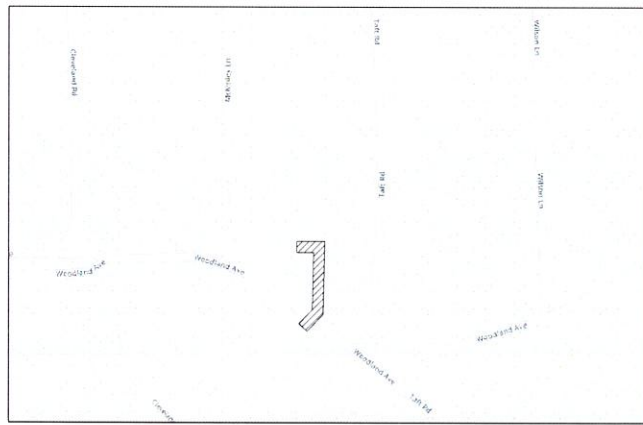

NOT TO SCALE

LEGEND

SYMBOLS	
JOINT POLE	TRANSFORMER POLE
POWER POLE	TELEPHONE POLE
CATV POLE	EXP SERVICE RISER
CATV VAULT	UTILITY AND ANCHOR
TELECO VAULT	TRAFFIC CONTROL VAULT
CATV PED	UNMARKED VAULT
CATV LOCKBOX	BORE SPURCE RIT
FIRE HYDRANT	CATV POWER SUPPLY
CATCH BASIN	AIR CONDITIONER
SEWER DRAIN	GENERATOR
SULFUR PIPE	WATER METER
WATER VALVE	UNMARKED MANHOLES
GAS VALVE	CATV MANHOLE
TELECO PED	ELECTRIC MANHOLE
TRANSFORMER	TRAFFIC MANHOLE
MAIL BOX	TELEPHONE MANHOLE
RISER MARKER	SEWER MANHOLE
GAS METER	WATER SERVICE (NOT)
ROAD SIGN	WATER MANHOLE
R R XING GATE	GAS MARKER
FREE	RIGHT-OF-WAY MARKER
BUSH	TRAFFIC SIGNAL LIGHT
STREET LIGHT	ELECTRIC VAULTED METER

LINES	
---	CENTER LINE
---	RIGHT-OF-WAY LINE
---	PROPERTY LINE
---	UTILITY EASEMENT
---	OVERHEAD CABLE
---	DIRECTIONAL BORE CABLE
---	FRENCH CABLE
---	EXISTING PRECONDUIT
---	HAND-BURY CABLE
---	WATER MAIN
---	SANITARY SEWER
---	STORM SEWER MAIN
---	GAS MAIN
---	TELEPHONE CABLE
---	BURIED ELECTRIC CABLE
---	FENCE

Comcast

THE INFORMATION IN THIS DRAWING IS THE PROPERTY OF COMCAST AND MAY NOT BE REPRODUCED OR TRANSMITTED IN ANY FORM OR BY ANY MEANS WITHOUT WRITTEN PERMISSION FROM COMCAST.

AXIS POINTS

FOR NO: **AXS-18496762RP**

PROJECT TITLE: **COMCAST U-GROUND COMMUNICATION CABLE REPLACEMENT**

LOCATION: **810 TAFT RD, HINSDALE, IL**

DRAWING NO: **AXS-18496762RP**

SHEET NO: **1 OF 2**

ESPO ENGINEERING

1450 W. 11TH ST. SUITE 100, CHICAGO, IL 60607

TEL: 773.233.1111 FAX: 773.233.1112

WWW.ESPOENGINEERING.COM

ENG NUMBER: **AXS-20-2847**

DRAWN BY: **NYS** DATE: **11/3/2020**

ISSUED FOR PERMITTING

SCALE: **1"=50'**

REVISIONS

DATE	BY	DESCRIPTION

COOK COUNTY
LYONS TWP T38N R12E
S.W. 1/4 OF S.W. 1/4 OF SEC. 7

INDEX OF SHEETS

1. COVER SHEET

2. PLAN SHEET


PROJECT DESCRIPTION


PROPOSED REPLACEMENT OF
UNDERGROUND CABLE -
2" HDPE W/1'-625 COAX
@ 36" MIN. DEPTH
BY DIRECTIONAL BORING

PROJECT DETAIL

CABLE LENGTH (ft): **301**

COMCAST COORD: **BERNADETTE DALCOUR**

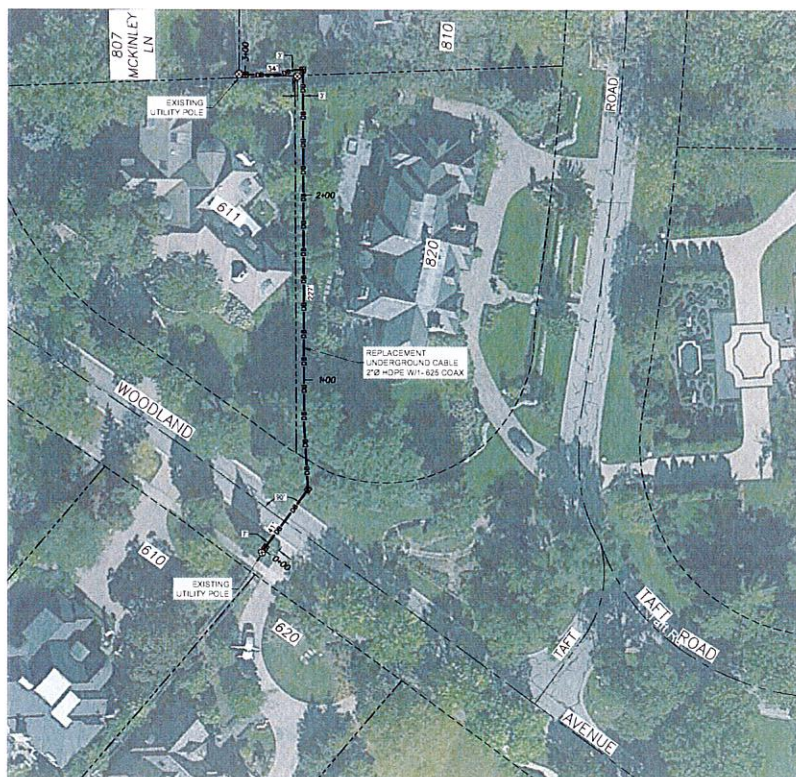


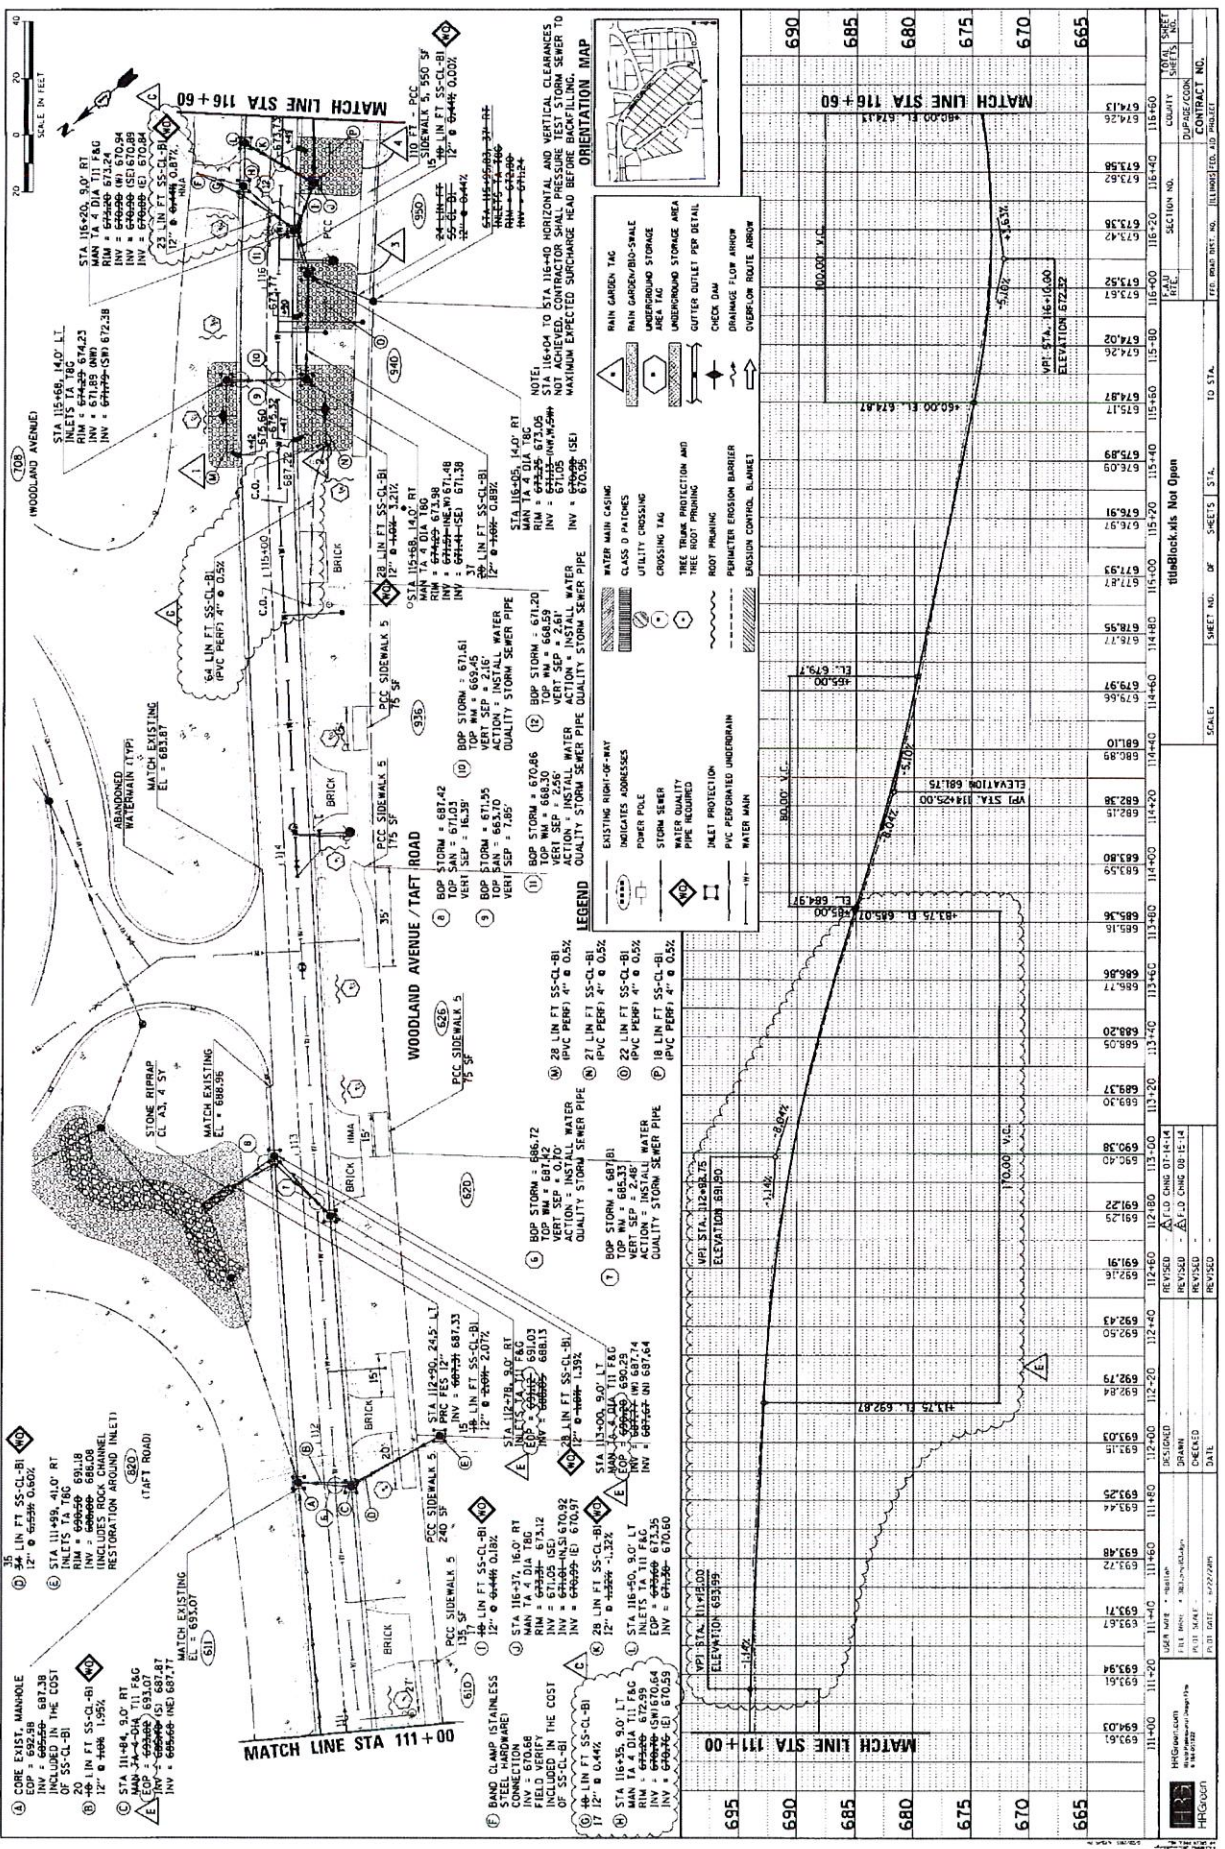

ORIENTATION MAP

LEGEND

- EXISTING RIGHT-OF-WAY
- INDICATES ADDRESSES
- POWER POLE
- STORM SEWER
- PIPE REQUIRED
- PIPE PROTECTION
- PVC PERFORATED UNDERDRAIN
- WATER MAIN
- RAIN GARDEN TAG
- RAIN GARDEN/BO-SHALE
- UNDERGROUND STORAGE
- UNDERGROUND STORAGE AREA
- CHECK DAM
- OUTLET OUTLET PER DETAIL
- OVERFLOW ROUTE ARROW
- OVERFLOW ROUTE ARROW
- OVERFLOW ROUTE ARROW

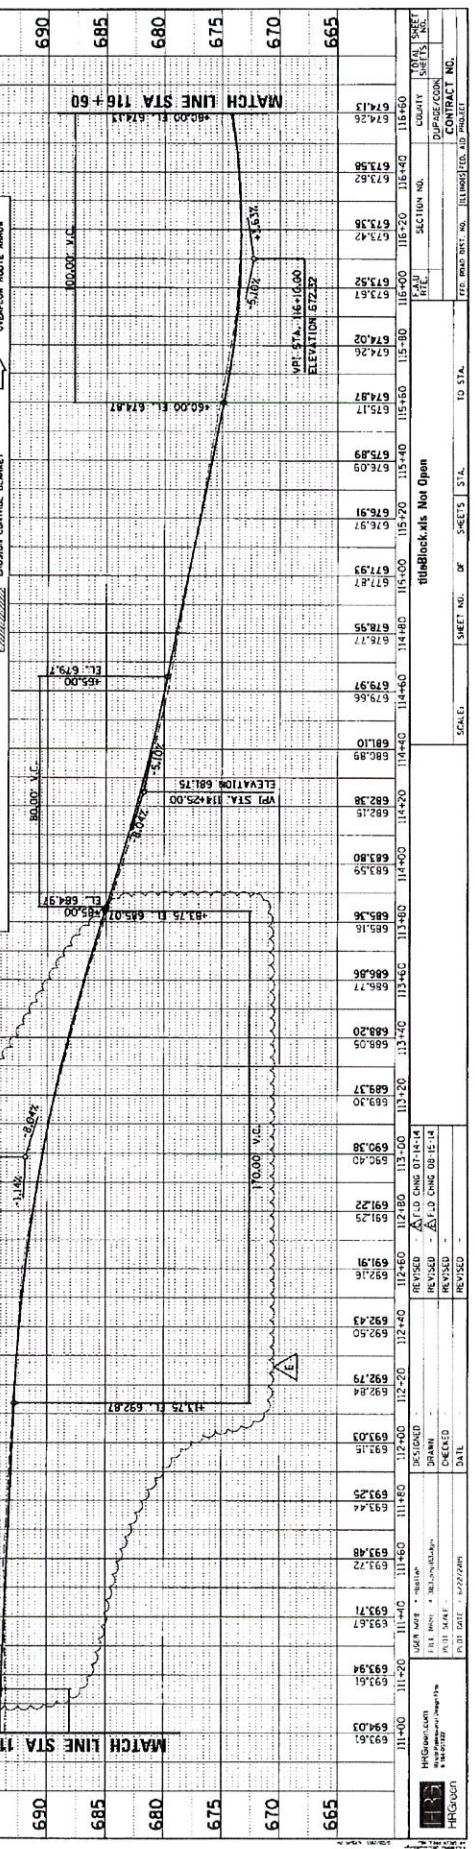

REVISION	DATE	BY	CHKD	DATE	BY	CHKD
REVISED	07-14-14	...	...	...	...	...
REVISED	08-15-14	...	...	...	...	...
REVISED	...	...	...	...	...	...
REVISED	...	...	...	...	...	...

DESIGNED	...	...	...	...	...	...
FILED	...	...	...	...	...	...
PLT	...	...	...	...	...	...
DATE	...	...	...	...	...	...

SCALE	SHEET NO.	DF	SHEET'S	STA.	TO STA.
...	...	...	...	...	...

SECTION NO.	CONTRACT NO.	DATE	BY	CHKD
...	...	...	...	...