



Village of Hinsdale
19 E. Chicago Avenue
Hinsdale, IL 60521-3489
(630)789-7000

Village Website: www.villageofhinsdale.org

PUBLIC SERVICES UTILITY PERMIT APPLICATION

Date of Application: 12/15/20

Permit No: Comcast0036

Permit Expiration Date: 01-15-2021

Utility Company Information:

Company Name: Comcast Cable
Address: 5N301 Medinah Rd
City, State, Zip: Addison, IL 60101
Contact Person: Adriana Candia
Phone Number: 224.229.6594
Email Address: adriana_candia@comcast.com
Cell Number: 224.343.0938
Project/Work Order Number: TAC-JB518206ME

Contractor Information:

Company Name: Talon Communications
Address: 305 Amston Ct.
City, State, Zip: Oswego, IL 60543
Contact Person: Bill Zebrauskas
Phone Number: 630.538.5070
Email Address: billzebrauskas@gmail.com
Cell Number: 630.538.5070

PROJECT LOCATION: 777 N York Road

Description of work covered under this permit: Install new aerial CATV fiber optic cable between nine existing utility poles located along Fuller Road & N York Road. Then to install underground CATV fiber optic cable to building 777 N York Road as shown on the drawing.

Start Date: 12-29-20

Completion Date: 12-30-20

Site Plan/Details/Specifications (3 sets) included with application?

☒ YES

☐ NO

Certificate of Insurance included with application?

☒ YES

☐ NO

Type of Utility:

☐ ComEd

☐ Nicor

☒ Comcast

☐ Water

☐ Sewer

☐ Communications:

☐ Fiber Optic

☐ Wireless

☐ Other:

Applicant Information:

Print Name: Olivia Carlin

Phone Number: 630.522.3024

Company: ESPO Engineering

Email Address: ocarlin@espocorp.com

Signature: Olivia Carlin

Date: 12/15/20

ALL CONSTRUCTION SHALL BE DONE IN ACCORDANCE WITH THE LATEST EDITION IN EFFECT ON THE DATE OF PERMIT APPLICATION OF THE FOLLOWING: STANDARD SPECIFICATIONS FOR ROAD AND BRIDGE CONSTRUCTION & SUPPLEMENTAL SPECIFICATIONS AND RECURRING SPECIAL PROVISIONS BY THE ILLINOIS DEPARTMENT OF TRANSPORTATION, ILLINOIS MANUAL ON UNIFORM TRAFFIC CONTROL DEVICES FOR STREETS AND HIGHWAYS, STANDARD SPECIFICATIONS FOR WATER AND SEWER MAIN CONSTRUCTION IN ILLINOIS, AND THE VILLAGE OF HINSDALE SUBDIVISION ORDINANCE AND ENGINEERING STANDARDS.

Village Use Only

Permit Approved:

YES

NO

Conditions for Approval/Reasons for Denial: RESTORE ALL DISTURBED AREAS WITHIN 14 DAYS OF CABLE INSTALL. NOTIFY RESIDENTS OF PROJECT SCOPE AND SCHEDULE 48 HOURS PRIOR TO START.


Approved By:

A. Diaz

Date:

12/17/20

SITE MAP

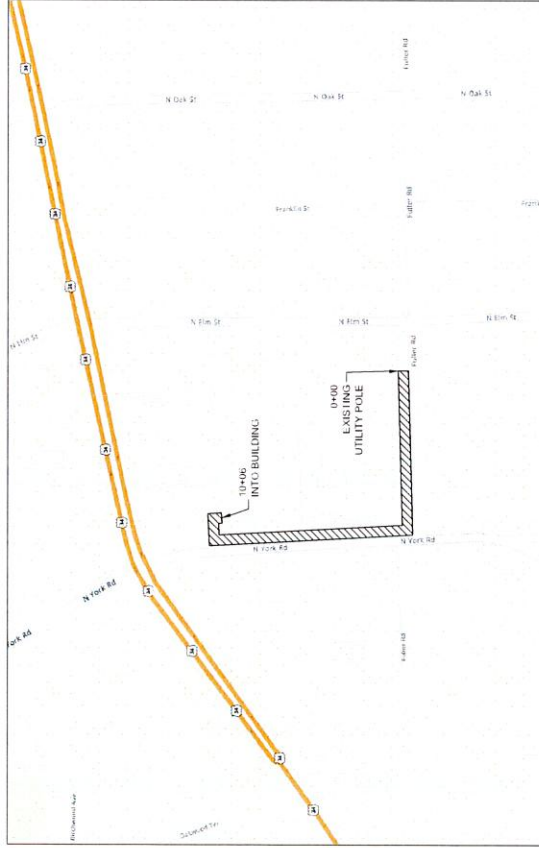

THE INFORMATION IN THIS DRAWING FILE IS PROPRIETARY AND CONFIDENTIAL AND MAY NOT BE REPRODUCED OR TRANSMITTED BY ANY MEANS OF CONVEYANCE WITHOUT WRITTEN PERMISSION FROM COMCAST.

JOB NO. TAC-JB518206ME
PROJECT TITLE: COMCAST AERIAL & U-G
COMMUNICATION CABLE
METRO-E
LOCATION: FULLER RD
@ 777 N YORK RD
HINSDALE, IL
DRAWING NO. TAC-JB518206ME
SHEET NO. 1 OF 3

ENG NUMBER: TAC-20-3079

DRAWN BY: AIPG	DATE 12/8/20
----------------	--------------

SCALE: 1"=50'

DESCRIPTION

DATE	BY	DESCRIPTION

[illegible]

DUPAGE COUNTY DOWNERS GROVE TWP T38N R11E N.W.1/4 OF NE 1/4 OF SEC.1	INDEX OF SHEETS 1. COVER SHEET 2-3. PLAN SHEETS	PROJECT DESCRIPTION PROPOSED INSTALLATION OF UNDERGROUND CABLE - Ø2" HDPE W/24CT F.O. CABLE @ 36" MIN. DEPTH BY DIRECTIONAL BORING & AERIAL - 24CT F.O. CABLE	PROJECT DETAIL CABLE LENGTH (ft): 1,006 COMCAST COORD. JACK PALMER
--	---	---	--

NOTE:
ALL POLES SHOWN
ARE EXISTING.

LEGEND

SYMBOLS

⊗ JOINT POLE

⊗ POWER POLE

⊗ EXF SERVICE RISER

⊗ CATV VAULT

⊗ TELE FACILITY

⊗ CATV LOCKBOX

⊗ FIRE HYDRANT

⊗ CATCH BASIN

⊗ SLEWER DRAIN

⊗ CULVERT PPPL

⊗ WATER VALVE

⊗ GAS VALVE

⊗ TELE CO PED

⊗ TRANSFORMER

⊗ MAIL BOX

⊗ FIBER MARKER

⊗ GAS METER

⊗ ROAD SIGN

⊗ TREE

⊗ STREET LIGHT

⊗ ELECTRIC VAULT/FEDMETER

⊗ TRANSFORMER POLE

⊗ TELEPHONE POLE

⊗ EXF SERVICE RISER

⊗ CATV AND ANCHOR

⊗ TRAFFIC CONTROL VAULT

⊗ UNMARKED VAULT

⊗ BUREAU/SPICE PIT

⊗ CATV POWER SUPPLY

⊗ AIR CONDITIONER

⊗ GENERATOR

⊗ WATER METER

⊗ UNMARKED MANHOLES

⊗ CATV MANHOLE

⊗ ELECTRIC MANHOLE

⊗ TELEPHONE MANHOLE

⊗ SLEWER MANHOLE

⊗ WATER MANHOLE

⊗ (includes downspout & E (HAC))

⊗ (includes downspout & E (HAC))

⊗ RIGHT-OF-WAY MARKER

⊗ TRAFFIC SIGNAL LIGHT

LINES

— CENTER LINE

— RIGHT-OF-WAY LINE

— UTILITY EASEMENT

— OVERHEAD CABLE

— DIRECTIONAL BORE CABLE

— EXISTING 15" PPPL CONDUIT

— EXISTING 18" PPPL CONDUIT

— WATER MAIN

— STORM SEWER MAIN

— GAS MAIN

— TELECO CABLE

— EXISTING ELECTRIC CABLE

— FENCE

Comcast

THE INFORMATION IN THIS DRAWING FILE IS
PROPRIETARY AND CONFIDENTIAL AND MAY
NOT BE REPRODUCED OR TRANSMITTED IN
ANY FORM OR BY ANY MEANS WITHOUT
WRITTEN PERMISSION FROM COMCAST.

TALON COMMUNICATIONS

JOB NO. TAC-JB519206ME

PROJECT TITLE COMCAST AERIAL & U-G
COMMUNICATION CABLE
METRO-E

LOCATION FULLER RD
@ 777 N YORK RD
HINSDALE, IL

DRAWING NO. TAC-JB519206ME

SHEET NO. 2 OF 3

ESPO ENGINEERING

945 GARDEN CITY AVENUE, SUITE 100
GARDEN CITY, NY 11530
516.466.1100
www.espoengineers.com

ENG NUMBER: TAC-20-3079

DRAWN BY: APC DATE: 12/6/20

ISSUED FOR PERMITTING

SCALE: 1"=50'

REVISIONS

DATE	BY	DESCRIPTION

LEGEND

- SYMBOLS**
- ⊗ JOINT POLE
 - ⊗ POWER POLE
 - ⊗ CATV POLE
 - ⊗ EXF SERVICE RISER
 - ⊗ GUY AND ANCHOR
 - ⊗ TRAFFIC CONTROL VAULT
 - ⊗ UNMARKED VAULT
 - ⊗ CATV PED
 - ⊗ CATV PED BOX
 - ⊗ FIBER HYDRANT
 - ⊗ CATV POWER SUPPLY
 - ⊗ AIR CONDITIONER
 - ⊗ GENERATOR
 - ⊗ SEWER DRAIN
 - ⊗ CULVERT PIPE
 - ⊗ WATER VALVE
 - ⊗ UNMARKED MANHOLE
 - ⊗ CATV MANHOLE
 - ⊗ ELECTRICAL MANHOLE
 - ⊗ TELEPHONE MANHOLE
 - ⊗ SILENT MANHOLE
 - ⊗ GAS METER
 - ⊗ ROAD SIGN
 - ⊗ R.R. CROSSING
 - ⊗ TREE
 - ⊗ STREET LIGHT
 - ⊗ RIGHT-OF-WAY MARKER
 - ⊗ BUS STOP
 - ⊗ ELECTRIC VAULT/FEDMETER
- LINE**
- CENTER LINE
 - RIGHT-OF-WAY LINE
 - PROPERTY LINE
 - OVERHEAD CABLE
 - DIRECTIONAL BORE CABLE
 - TRENCH CABLE
 - TRENCH CABLE CONDUIT
 - WATER MAIN
 - SANITARY SEWER
 - GAS MAIN
 - BURIED ELECTRIC CABLE
 - FURFILL



THE INFORMATION IN THIS DRAWING FILE IS
PROPRIETARY AND CONFIDENTIAL AND MAY
NOT BE REPRODUCED OR TRANSMITTED IN
ANY FORM OR BY ANY MEANS WITHOUT
WRITTEN PERMISSION FROM COMCAST.

TALON COMMUNICATIONS

JOB NO. TAC-JB518206ME
PROJECT TITLE COMCAST AERIAL & U-G
COMMUNICATION CABLE
METRO-E
LOCATION FULLER RD
@ 777 N YORK RD
HINSDALE, IL
DRAWING NO. TAC-JB518206ME
SHEET NO. 3 OF 3

ESPO ENGINEERING
465 HAZARD AVENUE, SUITE 100, HINSDALE, IL 60521
www.espoengineers.com

ENG NUMBER: TAC-20-3079

DRAWN BY: JMC DATE: 12/2/20

ISSUED FOR PERMITTING

SCALE: 1"=50'

REVISIONS

DATE	BY	DESCRIPTION

