



Village of Hinsdale
19 E. Chicago Avenue
Hinsdale, IL 60521-3489
(630)789-7000

Village Website: www.villageofhinsdale.org

PUBLIC SERVICES UTILITY PERMIT APPLICATION - Permit Fee of \$100.00

Date of Application: 04/8/21 Permit No: COMCAST-040 Permit Expiration Date: _____

Utility Company Information:

Company Name: Comcast Cable
Address: 5N301 Medinah Rd
City, State, Zip: Addison, IL 60101
Contact Person: Adriana Candia
Phone Number: 224.229.6594
Email Address: adriana_candia@comcast.com
Cell Number: 224.343.0938
Project/Work Order Number: TAC-JB593795NS

Contractor Information:

Company Name: Talon Communications
Address: 305 Amston Ct.
City, State, Zip: Oswego, IL 60543
Contact Person: Bill Zebrauskas
Phone Number: 630.538.5070
Email Address: billzebrauskas@gmail.com
Cell Number: 630.538.5070

PROJECT LOCATION: Walnut Street @ County Line Road

Description of work covered under this permit: Install new aerial CATV fiber optic cable between twelve existing utility poles located along Walnut Street and in the rear of 212 - 236 County Line Road as shown on the drawing.

Estimated Cost: \$8,835

Start Date: ~~4-22-21~~ 05/10/21 Completion Date: ~~4-22-21~~ 05/14/21

Site Plan/Details/Specifications (3 sets) included with application? YES NO
Currently registered as a Utility Contractor with the Village of Hinsdale? YES NO
Engineer Estimate of Cost included with application? YES NO

Type of Utility: ComEd Nicor Comcast Water Sewer
 Communications: Fiber Optic Wireless Other: _____

Applicant Information:

Print Name: Olivia Carlin Phone Number: 630.522.3024
Company: ESPO Engineering on behalf of Comcast Cable Email Address: ocarlin@es pocorp.com
Signature: *Olivia Carlin* Date: 4-8-21

ALL CONSTRUCTION SHALL BE DONE IN ACCORDANCE WITH THE LATEST EDITION IN EFFECT ON THE DATE OF PERMIT APPLICATION OF THE FOLLOWING: STANDARD SPECIFICATIONS FOR ROAD AND BRIDGE CONSTRUCTION & SUPPLEMENTAL SPECIFICATIONS AND RECURRING SPECIAL PROVISIONS BY THE ILLINOIS DEPARTMENT OF TRANSPORTATION, ILLINOIS MANUAL ON UNIFORM TRAFFIC CONTROL DEVICES FOR STREETS AND HIGHWAYS, STANDARD SPECIFICATIONS FOR WATER AND SEWER MAIN CONSTRUCTION IN ILLINOIS, AND THE VILLAGE OF HINSDALE SUBDIVISION ORDINANCES (Ord. 02007-73, 11-6-2007) AND ENGINEERING STANDARDS.

Village Use Only


Permit Approved: YES NO

Conditions for Approval/Reasons for Denial: Restore all disturbed areas within 14 DAYS of completion. NOTIFY VILLAGE AND RESIDENTS 48 HOURS PRIOR TO START.

Approved By: *Jeff. A. Diaz* Date: 04/29/21

VILLAGE OF HINSDALE PERMIT DRAWINGS WALNUT ST & COUNTY LINE RD HINSDALE, IL

SITE MAP

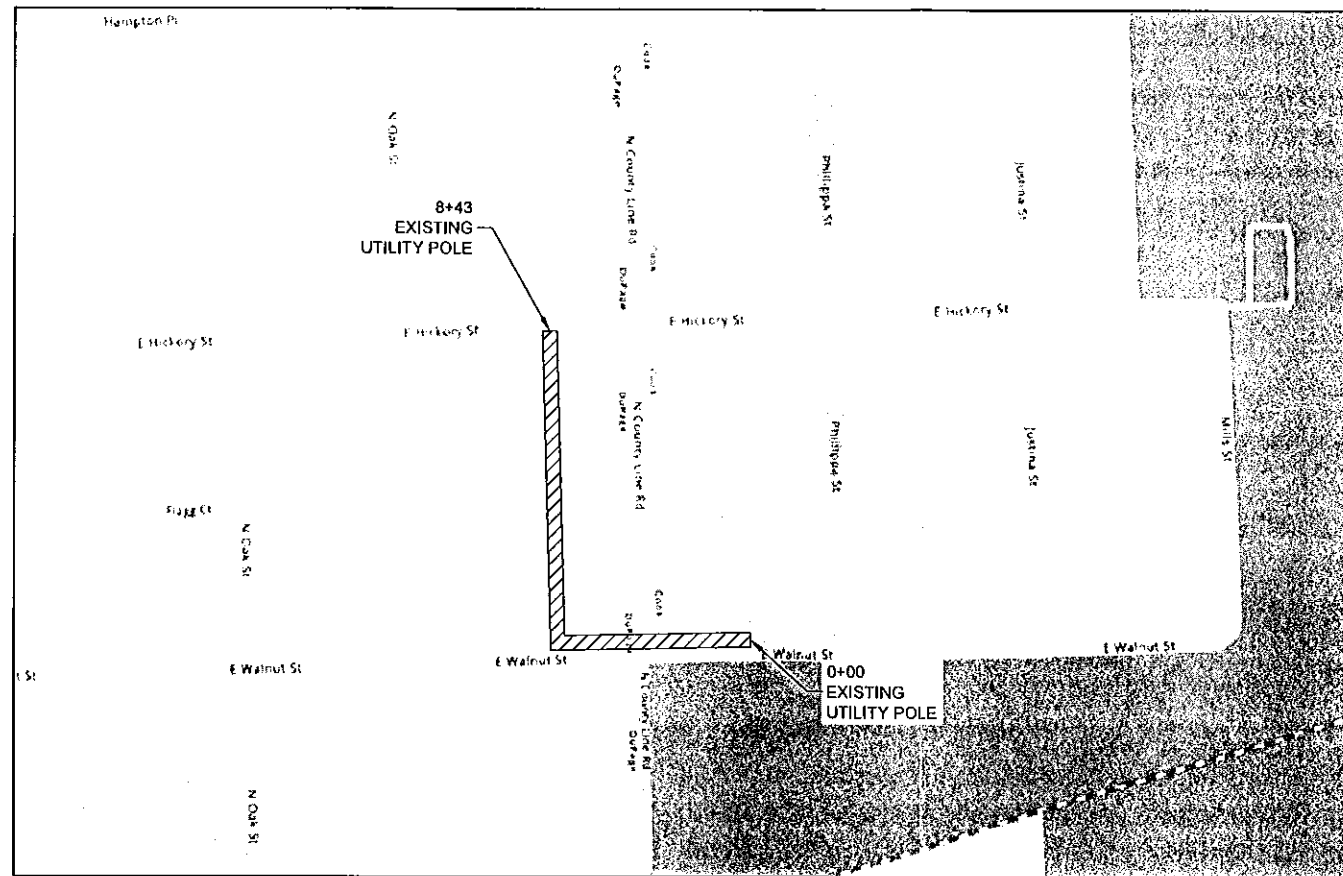

NOT TO SCALE

LEGEND

SYMBOLS	
⊗ JOINT POLE	⊗ TRANSFORMER POLE
× POWER POLE	○ TELEPHONE POLE
● CATV POLE	⊗ EXF SERVICE RISER
⊞ CATV VAULT	⊗ GUY AND ANCHOR
⊞ TELCO VAULT	⊞ TRAFFIC CONTROL VAULT
□ CATV PED	⊞ UNMARKED VAULT
⊞ CATV LOCKBOX	⊞ BORE/SPLICE PIT
⊞ FIRE HYDRANT	⊞ CATV POWER SUPPLY
⊞ CATCH BASIN	⊞ AIR CONDITIONER
⊞ SEWER DRAIN	⊞ GENERATOR
⊞ CULVERT PIPE	⊞ WATER METER
⊞ WATER VALVE	⊞ UNMARKED MANHOLES
⊞ GAS VALVE	⊞ CATV MANHOLE
⊞ TELCO PED	⊞ ELECTRIC MANHOLE
⊞ TRANSFORMER	⊞ TRAFFIC MANHOLE
⊞ MAIL BOX	⊞ TELEPHONE MANHOLE (Indicate Ownership)
⊞ FIBER MARKER	⊞ SEWER MANHOLE (Indicate Sanitary/Storm)
⊞ GAS METER	⊞ WATER MANHOLE (Indicate Ownership e.g. DWC)
⊞ ROAD SIGN	⊞ GAS MARKER (Indicate Ownership)
⊞ R.R. X-ING GATE	⊞ RIGHT-OF-WAY MARKER (Bench Mark)
⊞ TREE	⊞ TRAFFIC SIGNAL LIGHT
⊞ BUSH	
⊞ STREET LIGHT	
⊞ ELECTRIC VAULT/ PED/METER	

LINES	
—	CENTER LINE
- - - -	RIGHT-OF-WAY LINE
- · - · -	PROPERTY LINE
- · - · -	UTILITY EASEMENT
—AER—	OVERHEAD CABLE
—DB—	DIRECTIONAL BORE CABLE
—TR—	TRENCH CABLE
—EX—	EXISTING PIPE/CONDUIT
—HB—	HAND-BURY CABLE
—W—	WATER MAIN
—S—	SANITARY SEWER
—G—	STORM SEWER MAIN
—TEL—	GAS MAIN
—E—	TELCO CABLE
—E—	BURIED ELECTRIC CABLE
—	FENCE



THE INFORMATION IN THIS DRAWING FILE IS PROPRIETARY AND CONFIDENTIAL AND MAY NOT BE REPRODUCED OR TRANSMITTED BY ANY MEANS OF CONVEYANCE WITHOUT WRITTEN PERMISSION FROM COMCAST.

TALON COMMUNICATIONS
305 AMSTON CT, OSWEGO IL 60543; (830) 326-4951

JOB NO.: TAC-JB593795NS
PROJECT TITLE: COMCAST AERIAL & U-G COMMUNICATION CABLE NODE SEGMENT
LOCATION: WALNUT ST & COUNTY LINE RD HINSDALE, IL
DRAWING NO. TAC-JB593795NS
SHEET NO. 1 OF 2

ESPO ENGINEERING
845 MIDWAY DR WILLOWBROOK, IL 60527
630.789.2525
www.espocorp.com

ENG NUMBER: TAC-21-0618

DRAWN BY: SOA DATE: 04/07/21

ISSUED FOR PERMITTING

SCALE: N.T.S.

REVISIONS		
DATE	BY	DESCRIPTION
-	-	-
-	-	-
-	-	-

COOK COUNTY
LYONS TWP T38N R12E
S.W.1/4 OF S.W.1/4 OF SEC.6
DUPAGE COUNTY
DOWNERS GROVE TWP T38N R11E
S.E.1/4 OF S.E.1/4 OF SEC.1

INDEX OF SHEETS
1. COVER SHEET
2. PLAN SHEET

PROJECT DESCRIPTION
PROPOSED INSTALLATION OF
UNDERGROUND CABLE -
Ø2" HDPE w/48CT F.O. CABLE
@ 36" MIN. DEPTH
BY DIRECTIONAL BORING
& AERIAL - 48CT F.O. CABLE

PROJECT DETAIL
CABLE LENGTH (ft): 843
COMCAST COORD:

NOTE:
ALL POLES SHOWN
ARE EXISTING.



LEGEND

- SYMBOLS**
- ⊗ JOINT POLE
 - × POWER POLE
 - CATV POLE
 - ⌚ CATV VAULT
 - ⌚ TELCO VAULT
 - ⌚ CATV PED
 - ⌚ CATV LOCKBOX
 - ⌚ FIRE HYDRANT
 - ⌚ CATCH BASIN
 - ⌚ SEWER DRAIN
 - ⌚ CULVERT PIPE
 - ⌚ WATER VALVE
 - ⌚ GAS VALVE
 - ⌚ TELCO PED
 - ⌚ TRANSFORMER
 - ⌚ MAIL BOX
 - ⌚ FIBER MARKER
 - ⌚ GAS METER
 - ⌚ ROAD SIGN
 - ⌚ R.R. X-ING GATE
 - ⌚ TREE
 - ⌚ BUSH
 - ⌚ STREET LIGHT
 - ⌚ ELECTRIC VAULT/ PED/METER
 - ⊗ TRANSFORMER POLE
 - TELEPHONE POLE
 - ⊗ EXF SERVICE RISER
 - ⊗ GUY AND ANCHOR
 - ⌚ TRAFFIC CONTROL VAULT
 - ⌚ UNMARKED VAULT
 - ⌚ BORE/SPLICE PIT
 - ⌚ CATV POWER SUPPLY
 - ⌚ AIR CONDITIONER
 - ⌚ GENERATOR
 - ⌚ WATER METER
 - ⌚ UNMARKED MANHOLES
 - ⌚ CATV MANHOLE
 - ⌚ ELECTRIC MANHOLE
 - ⌚ TRAFFIC MANHOLE
 - ⌚ TELEPHONE MANHOLE (Indicate Ownership)
 - ⌚ SEWER MANHOLE (Indicate Sanitary/Storm)
 - ⌚ WATER MANHOLE (Indicate Ownership e.g. DWC)
 - ⌚ GAS MARKER (Indicate Ownership)
 - ⌚ RIGHT-OF-WAY MARKER (Bench Mark)
 - ⌚ TRAFFIC SIGNAL LIGHT

- LINES**
- CENTER LINE
 - RIGHT-OF-WAY LINE
 - PROPERTY LINE
 - UTILITY EASEMENT
 - AER OVERHEAD CABLE
 - DB DIRECTIONAL BORE CABLE
 - TR TRENCH CABLE
 - EX EXISTING PIPE/CONDUIT
 - HB HAND-BURY CABLE
 - W WATER MAIN
 - S SANITARY SEWER
 - SS STORM SEWER MAIN
 - G GAS MAIN
 - TEL TELCO CABLE
 - E BURIED ELECTRIC CABLE
 - ○ FENCE



THE INFORMATION IN THIS DRAWING FILE IS PROPRIETARY AND CONFIDENTIAL AND MAY NOT BE REPRODUCED OR TRANSMITTED BY ANY MEANS OF CONVEYANCE WITHOUT WRITTEN PERMISSION FROM COMCAST.

TALON COMMUNICATIONS
305 AMSTON CT, OSWEGO IL 60543 ; (830) 926-4951

JOB NO.: TAC-JB593795NS
PROJECT TITLE: COMCAST AERIAL & U-G COMMUNICATION CABLE NODE SEGMENT

LOCATION: WALNUT ST & COUNTY LINE RD HINSDALE, IL

DRAWING NO. TAC-JB593795NS
SHEET NO. 2 OF 2

ESPO ENGINEERING
845 MIDWAY DR WILLOWBROOK, IL 60527
630.789.2525
www.espocorp.com

ENG NUMBER: TAC-21-0618
DRAWN BY: SOA DATE: 04/07/21

ISSUED FOR PERMITTING
SCALE: 1"=50'

REVISIONS		
DATE	BY	DESCRIPTION
-	-	-
-	-	-
-	-	-