



Village of Hinsdale
19 E. Chicago Avenue
Hinsdale, IL 60521-3489
(630)789-7000

Village Website: www.villageofhinsdale.org

PUBLIC SERVICES UTILITY PERMIT APPLICATION - Permit Fee of \$100.00

Date of Application: 7/19/21 Permit No: COMCAST-0043 Permit Expiration Date: 10/31/21

Utility Company Information:

Company Name: Comcast Cable
Address: 880 Donata Road
City, State, Zip: Lake Zurich, IL 60047
Contact Person: Phillip Jones
Phone Number: 224.229.4455
Email Address: phillip_jones@comcast.com
Cell Number: 630.688.7432
Project/Work Order Number: DCS-JB718521RP

Contractor Information:

Company Name: Directional Construction Services
Address: 440 S Dartmoor Drive
City, State, Zip: Crystal Lake, IL 60014
Contact Person: Scott Jones
Phone Number: 847.875.7153
Email Address: dcsjones@gmail.com
Cell Number: 847.875.7153

PROJECT LOCATION: along Barton Lane and to rear of 5525 Barton Lane

Description of work covered under this permit: Install replacement CATV coax cable between existing CATV pedestal along Barton Lane and to rear of 5525 Barton Lane as shown on the drawing. All CATV cable will be installed underground by directional boring in the same location as existing damaged cable.

Estimated Cost: \$5512

Start Date: 7/29/21

Completion Date: 7/29/21

Site Plan/Details/Specifications (3 sets) included with application?
Currently registered as a Utility Contractor with the Village of Hinsdale?
Engineer Estimate of Cost included with application?

☒ YES ☐ NO
☒ YES ☐ NO
☒ YES ☐ NO

Type of Utility:

☐ ComEd ☐ Nicor ☒ Comcast ☐ Water ☐ Sewer
☐ Communications: ☐ Fiber Optic ☐ Wireless ☐ Other: _____

Applicant Information:

Print Name: Olivia Carlin

Phone Number: 630.522.3024

Company: ESPO Engineering on behalf of Comcast Cable

Email Address: ocarlin@espocorp.com

Signature: Olivia Carlin

Date: 7/16/21

ALL CONSTRUCTION SHALL BE DONE IN ACCORDANCE WITH THE LATEST EDITION IN EFFECT ON THE DATE OF PERMIT APPLICATION OF THE FOLLOWING: STANDARD SPECIFICATIONS FOR ROAD AND BRIDGE CONSTRUCTION & SUPPLEMENTAL SPECIFICATIONS AND RECURRING SPECIAL PROVISIONS BY THE ILLINOIS DEPARTMENT OF TRANSPORTATION, ILLINOIS MANUAL ON UNIFORM TRAFFIC CONTROL DEVICES FOR STREETS AND HIGHWAYS, STANDARD SPECIFICATIONS FOR WATER AND SEWER MAIN CONSTRUCTION IN ILLINOIS, AND THE VILLAGE OF HINSDALE SUBDIVISION ORDINANCES (Ord. 02007-73, 11-6-2007) AND ENGINEERING STANDARDS.

Village Use Only

Permit Approved: YES NO


Conditions for Approval/Reasons for Denial: RESTORE ALL DISTURBED AREAS WITHIN 14 DAYS OF COMPLETION. NOTIFY RESIDENTS 48 HOURS PRIOR TO START.

Approved By: [Signature]

Date: 7/23/21

VILLAGE OF HINSDALE PERMIT DRAWING 5525 BARTON LN HILLSDALE, IL

SITE MAP

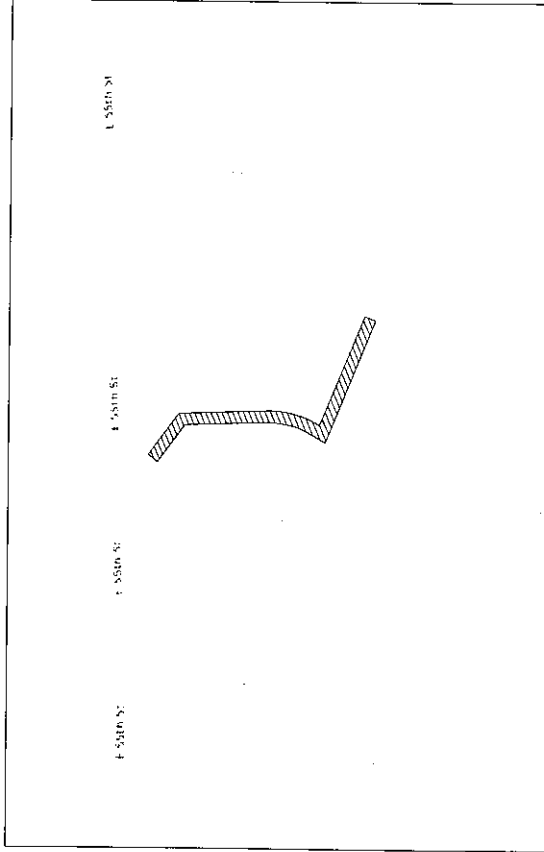

NOT TO SCALE

LEGEND	
SYMBOLS	
⊗	JOINT POLE
×	TRANSFORMER POLE
○	TELEPHONE POLE
●	EXF SERVICE RISER
⊕	CATV POLE
⊖	GUY AND ANCHOR
⊗	TRAFFIC CONTROL VAULT
⊕	TELECO VAULT
⊖	UNMARKED VAULT
⊗	CATV LOCKBOX
⊕	BOREHOLE PIT
⊖	FIRE HYDRANT
⊗	CATCH BASIN
⊕	SEWER MANHOLE
⊖	SEWER CLEANOUT
⊗	WATER VALVE
⊕	WATER TIE IN
⊖	UNMARKED MANHOLE
⊗	GAS VALVE
⊕	TELECO PED
⊖	TELEPHONE MANHOLE
⊗	MAIL BOX
⊕	FIBER MARKER
⊖	GAS METER
⊗	ROAD SIGN
⊕	R/R KING GATE
⊖	WATER MANHOLE
⊗	WATER VALVE
⊕	RIGHT-OF-WAY MARKER
⊖	BUSH
⊗	STREET LIGHT
⊕	ELECTRIC VAULT / PEDMETER
⊖	TRAFFIC SIGNAL LIGHT
LINES	
---	CENTER LINE
---	RIGHT-OF-WAY LINE
---	UTILITY EASEMENT
---	UTILITY easement
---	OVERHEAD CABLE
---	DIRECTIONAL BORE CABLE
---	EXISTING PIPE/CONDUIT
---	HAND-RURY CABLE
---	WALKWAY
---	STORM SEWER MAIN
---	GAS MAIN
---	TELECO CABLE
---	UNDERGROUND ELECTRIC CABLE
---	FENCE



THE INFORMATION IN THIS DRAWING FILE IS PROPRIETARY AND CONFIDENTIAL AND MAY BE USED FOR ANY PURPOSE WITHOUT ANY WRITTEN PERMISSION FROM COMCAST.

DIRECTIONAL CONSTR. SERVICES, INC.

JOB NO. DCS-18718521RP

PROJECT TITLE: COMCAST U/GROUND COMMUNICATION CABLE REPLACEMENT

LOCATION: 5525 BARTON LN HILLSDALE, IL

DRAWING NO. DCS-18718521RP

SHEET NO. 1 OF 2

ESPO ENGINEERING

601 MONROE ST. WILMINGTON, DE 19801

ENG NUMBER: DCS-21-1523

DRAWN BY: ERG

DATE: 07/16/21

ISSUED FOR PERMITTING

SCALE: N.T.S.

REVISIONS

DATE BY DESCRIPTION

COOK COUNTY
LYONS TWP 138N R12E
N.W. 1/4 OF N.W. 1/4 OF SEC 18

INDEX OF SHEETS
1. COVER SHEET
2. PLAN SHEET


PROJECT DESCRIPTION
PROPOSED REPLACEMENT OF UNDERGROUND CABLE - 2" HDPE W/1-525 COAX @ 36" MIN. DEPTH BY DIRECTIONAL BORING

PROJECT DETAIL
CABLE LENGTH (ft): 526
COMCAST COORD: BERNADETTE DALCOUR



VILLAGE OF HINSDALE
PERMIT DRAWING
5525 BARTON LN
HILLSDALE, IL

SITE MAP

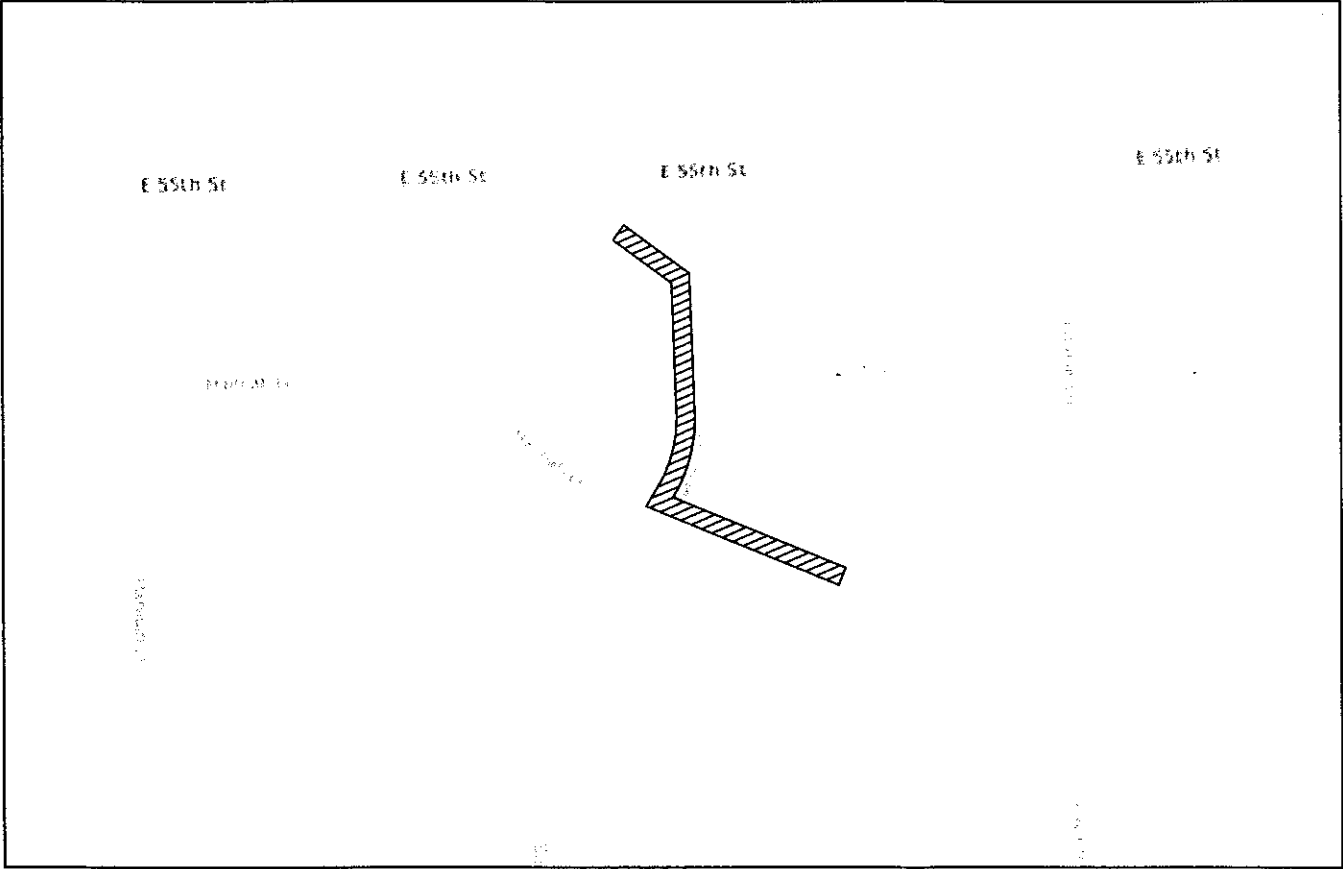

NOT TO SCALE

COOK COUNTY
LYONS TWP T38N R12E
N.W.1/4 OF N.W.1/4 OF SEC.18

INDEX OF SHEETS

1. COVER SHEET
2. PLAN SHEET

PROJECT DESCRIPTION

PROPOSED REPLACEMENT OF
UNDERGROUND CABLE -
2"Ø HDPE W/1-.625 COAX
@ 36" MIN. DEPTH
BY DIRECTIONAL BORING

PROJECT DETAIL

CABLE LENGTH (ft): 526

COMCAST COORD: BERNADETTE
DALCOUR

LEGEND

SYMBOLS

- | | |
|--------------------------------|--|
| ⊗ JOINT POLE | ⊗ TRANSFORMER POLE |
| × POWER POLE | ○ TELEPHONE POLE |
| ● CATV POLE | ⊗ EXF SERVICE RISER |
| ⊗ CATV VAULT | ⊗ GUY AND ANCHOR |
| ⊗ TELCO VAULT | ⊗ TRAFFIC CONTROL VAULT |
| □ CATV PED | ⊗ UNMARKED VAULT |
| ⊗ CATV LOCKBOX | ⊗ BORE/SPLICE PIT |
| ⊗ FIRE HYDRANT | ⊗ CATV POWER SUPPLY |
| ⊗ CATCH BASIN | ⊗ AIR CONDITIONER |
| ⊗ SEWER DRAIN | ⊗ GENERATOR |
| ⊗ CULVERT PIPE | ⊗ WATER METER |
| ⊗ WATER VALVE | ⊗ UNMARKED MANHOLES |
| ⊗ GAS VALVE | ⊗ CATV MANHOLE |
| ⊗ TELCO PED | ⊗ ELECTRIC MANHOLE |
| ⊗ TRANSFORMER | ⊗ TRAFFIC MANHOLE |
| ⊗ MAIL BOX | ⊗ TELEPHONE MANHOLE
(Indicate Ownership) |
| ⊗ FIBER MARKER | ⊗ SEWER MANHOLE
(Indicate Sanitary/Storm) |
| ⊗ GAS METER | ⊗ WATER MANHOLE
(Indicate Ownership e.g. DWC) |
| ⊗ ROAD SIGN | ⊗ GAS MARKER
(Indicate Ownership) |
| ⊗ R.R. X-ING GATE | ⊗ RIGHT-OF-WAY MARKER
(Bench Mark) |
| ⊗ TREE | ⊗ TRAFFIC SIGNAL LIGHT |
| ⊗ BUSH | |
| ⊗ STREET LIGHT | |
| ⊗ ELECTRIC VAULT/
PED/METER | |

LINES

- | | |
|---------------|------------------------|
| — | CENTER LINE |
| - - - | RIGHT-OF-WAY LINE |
| - - - | PROPERTY LINE |
| - - - | UTILITY EASEMENT |
| —AER—AER— | OVERHEAD CABLE |
| —DB—DB—DB— | DIRECTIONAL BORE CABLE |
| —TR—TR—TR— | TRENCH CABLE |
| —EX—EX—EX— | EXISTING PIPE/CONDUIT |
| —HB—HB—HB— | HAND-BURY CABLE |
| —W—W—W— | WATER MAIN |
| —S—S—S— | SANITARY SEWER |
| —G—G—G— | STORM SEWER MAIN |
| —TEL—TEL—TEL— | GAS MAIN |
| —E—E—E— | TELCO CABLE |
| —E—E—E— | BURIED ELECTRIC CABLE |
| —F—F—F— | FENCE |

Comcast

THE INFORMATION IN THIS DRAWING FILE IS
PROPRIETARY AND CONFIDENTIAL AND MAY
NOT BE REPRODUCED OR TRANSMITTED BY
ANY MEANS OF CONVEYANCE WITHOUT
WRITTEN PERMISSION FROM COMCAST.

DIRECTIONAL CONSTR. SERVICES, INC
440 S. DARTMOOR DRIVE, CRYSTAL LAKE, IL 60014, (815) 975-7153

JOB NO.: DCS-JB718521RP
PROJECT TITLE: COMCAST U-GROUND
COMMUNICATION CABLE
REPLACEMENT

LOCATION:
5525 BARTON LN
HILLSDALE, IL

DRAWING NO. DCS-JB718521RP
SHEET NO. 1 OF 2

ESPO ENGINEERING
845 MIDWAY DR WILLOWBROOK, IL 60527
630.789.2525
www.espcorp.com

ENG NUMBER: DCS-21-1523


DRAWN BY: ERO DATE: 07/16/21

ISSUED FOR PERMITTING

SCALE: N.T.S.

REVISIONS

DATE	BY	DESCRIPTION
-	-	-
-	-	-
-	-	-

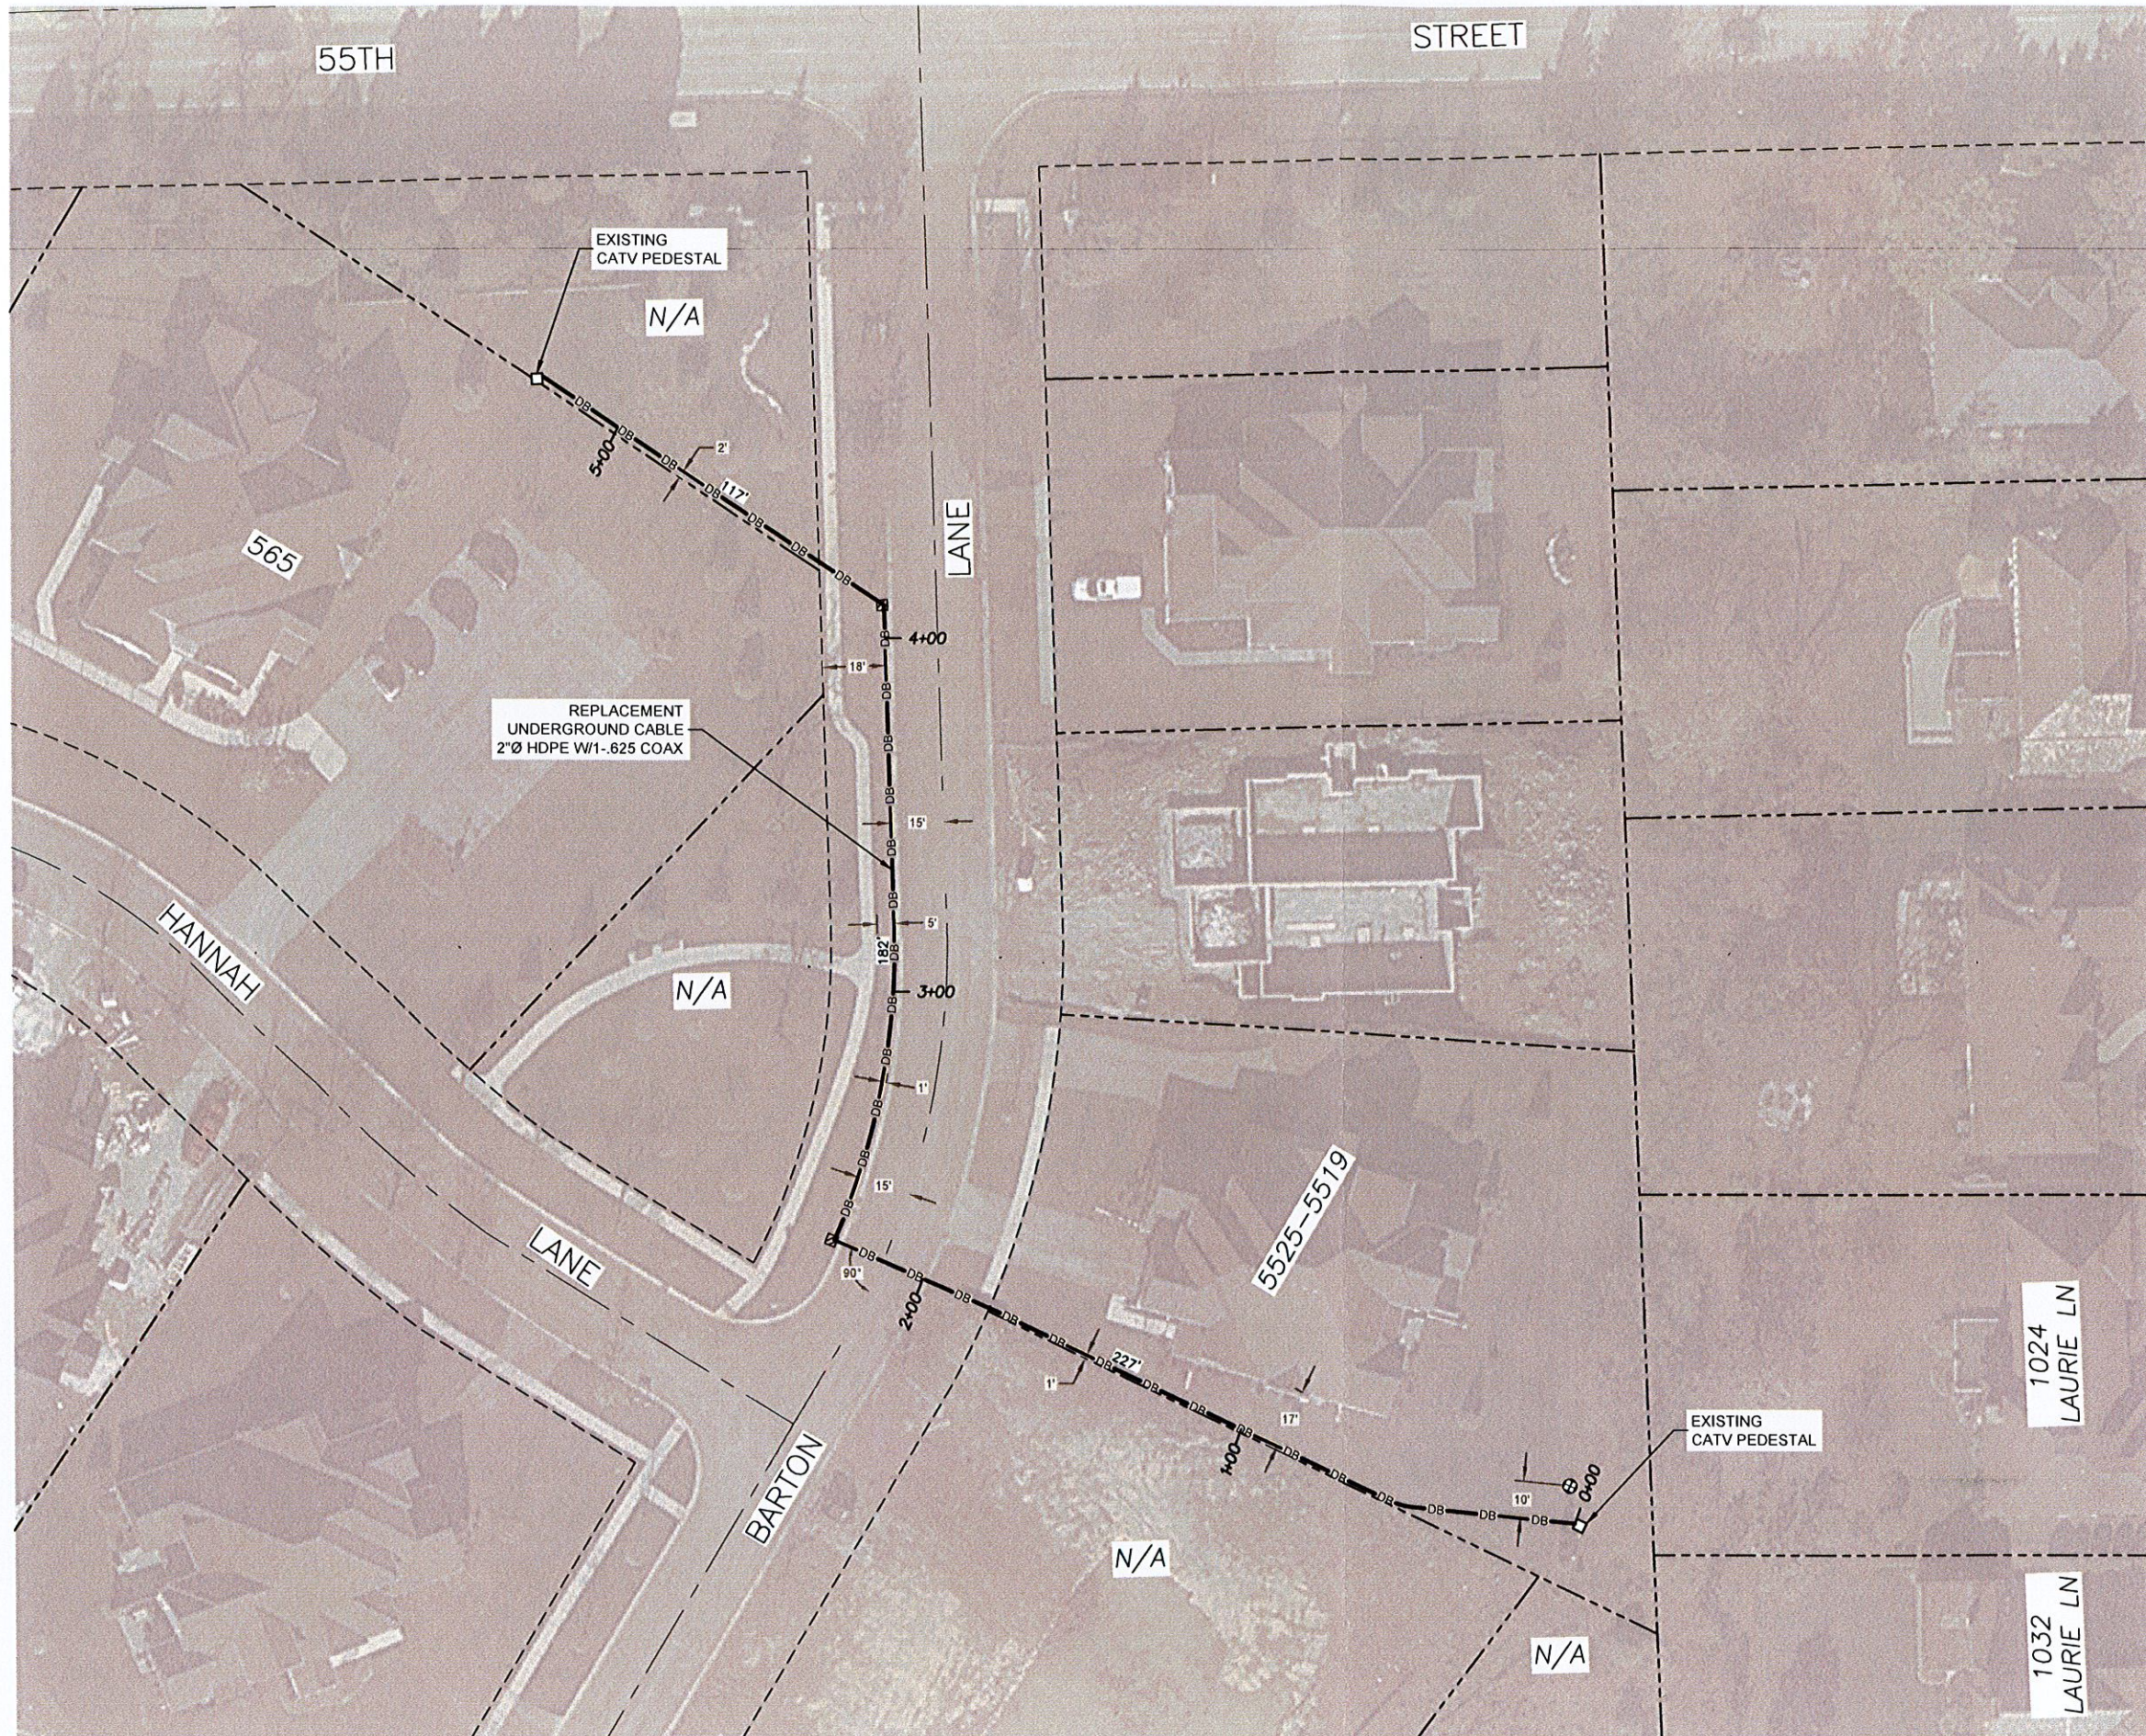

LEGEND

SYMBOLS

⊗ JOINT POLE	⊗ TRANSFORMER POLE
× POWER POLE	○ TELEPHONE POLE
● CATV POLE	⊗ EXF SERVICE RISER
⌚ CATV VAULT	⊗ GUY AND ANCHOR
⌚ TELCO VAULT	⌚ TRAFFIC CONTROL VAULT
□ CATV PED	□ UNMARKED VAULT
⊗ CATV LOCKBOX	⊗ BORE/SPLICE PIT
⊗ FIRE HYDRANT	⊗ CATV POWER SUPPLY
⊗ CATCH BASIN	⊗ AIR CONDITIONER
⊗ SEWER DRAIN	⊗ GENERATOR
⊗ CULVERT PIPE	⊗ WATER METER
⊗ WATER VALVE	⊗ UNMARKED MANHOLES
⊗ GAS VALVE	⊗ CATV MANHOLE
⊗ TELCO PED	⊗ ELECTRIC MANHOLE
⌚ TRANSFORMER	⌚ TRAFFIC MANHOLE
⌚ MAIL BOX	⌚ TELEPHONE MANHOLE (Indicate Ownership)
⌚ FIBER MARKER	⌚ SEWER MANHOLE (Indicate Sanitary/Storm)
⌚ GAS METER	⌚ WATER MANHOLE (Indicate Ownership e.g. DWC)
⌚ ROAD SIGN	⌚ GAS MARKER (Indicate Ownership)
⌚ R.R. X-ING GATE	⌚ RIGHT-OF-WAY MARKER (Bench Mark)
⌚ TREE	⌚ TRAFFIC SIGNAL LIGHT
⌚ BUSH	
⌚ STREET LIGHT	
⌚ ELECTRIC VAULT/ PED/METER	

LINES

—	CENTER LINE
- - -	RIGHT-OF-WAY LINE
- - -	PROPERTY LINE
- - -	UTILITY EASEMENT
—AER—AER—	OVERHEAD CABLE
—DB—DB—DB—	DIRECTIONAL BORE CABLE
—TR—TR—TR—	TRENCH CABLE
—EX—EX—EX—	EXISTING PIPE/CONDUIT
—HB—HB—HB—	HAND-BURY CABLE
—W—W—W—	WATER MAIN
—S—S—S—	SANITARY SEWER
—SS—SS—SS—	STORM SEWER MAIN
—G—G—G—	GAS MAIN
—TEL—TEL—TEL—	TELCO CABLE
—E—E—E—	BURIED ELECTRIC CABLE
—	FENCE

Comcast

THE INFORMATION IN THIS DRAWING FILE IS PROPRIETARY AND CONFIDENTIAL AND MAY NOT BE REPRODUCED OR TRANSMITTED BY ANY MEANS OF CONVEYANCE WITHOUT WRITTEN PERMISSION FROM COMCAST.

DIRECTIONAL CONSTR. SERVICES, INC
440 S. DARTMOOR DRIVE, CRYSTAL LAKE, IL 60014; (815) 875-7153

JOB NO.: DCS-JB718521RP
PROJECT TITLE: COMCAST U-GROUND COMMUNICATION CABLE REPLACEMENT
LOCATION: 5525 BARTON LN
HILLSDALE, IL
DRAWING NO. DCS-JB718521RP
SHEET NO. 2 OF 2

ESPO ENGINEERING
845 MIDWAY DR WILLOWBROOK, IL 60527
630.789.2525
www.espocorp.com

ENG NUMBER: DCS-21-1523
DRAWN BY: ERO DATE: 07/16/21
ISSUED FOR PERMITTING
SCALE: 1"=50'
REVISIONS

DATE	BY	DESCRIPTION
-	-	-
-	-	-
-	-	-