



Village of Hinsdale  
19 E. Chicago Avenue  
Hinsdale, IL 60521-3489  
(630)789-7000

Village Website: www.villageofhinsdale.org

**PUBLIC SERVICES UTILITY PERMIT APPLICATION**

Date of Application: 3/1/23 Permit No: N1602-0017 Permit Expiration Date: 4/30/23

**Utility Company Information:**

Company Name: Nicor Gas Company  
Address: 1844 W Ferry Road  
City, State, Zip: Naperville, IL 60563  
Contact Person: Heather Runge  
Phone Number: 630.388.3283  
Email Address: hrunge@southernco.com  
Cell Number: \_\_\_\_\_  
Project/Work Order Number: NCP-2757269

**Contractor Information:**

Company Name: Pipe Strong  
Address: 650 E Algonquin Road  
City, State, Zip: Schaumburg, IL 60173  
Contact Person: Mike Boyd  
Phone Number: 244.301.5977  
Email Address: mboyd@pipestrong.com  
Cell Number: \_\_\_\_\_

**PROJECT LOCATION:** 630 E 6TH ST

Description of work covered under this permit: Install gas service from 5x5 parkway tap located on E 6th Street R.O.W. and across to property for new service at building 630 E 6th Street.  
Permit to include road bore underneath E 6th Street.

**Start Date:** ASAP **Completion Date:** \_\_\_\_\_

Site Plan/Details/Specifications (3 sets) included with application?  YES  NO  
Certificate of Insurance included with application?  YES  NO

**Type of Utility:**  ComEd  Nicor  Comcast  Water  Sewer  
 Communications:  Fiber Optic  Wireless  Other: \_\_\_\_\_

**Applicant Information:**

Print Name: Olivia Carlin Phone Number: 630.522.3024  
Company: ESPO Engineering Email Address: ocarlin@espocorp.com  
Signature: Olivia Carlin Date: 3/1/23

ALL CONSTRUCTION SHALL BE DONE IN ACCORDANCE WITH THE LATEST EDITION IN EFFECT ON THE DATE OF PERMIT APPLICATION OF THE FOLLOWING: STANDARD SPECIFICATIONS FOR ROAD AND BRIDGE CONSTRUCTION & SUPPLEMENTAL SPECIFICATIONS AND RECURRING SPECIAL PROVISIONS BY THE ILLINOIS DEPARTMENT OF TRANSPORTATION, ILLINOIS MANUAL ON UNIFORM TRAFFIC CONTROL DEVICES FOR STREETS AND HIGHWAYS, STANDARD SPECIFICATIONS FOR WATER AND SEWER MAIN CONSTRUCTION IN ILLINOIS, AND THE VILLAGE OF HINSDALE SUBDIVISION ORDINANCE AND ENGINEERING STANDARDS.


**Village Use Only**

Permit Approved:  YES  NO

Conditions for Approval/Reasons for Denial: RESTORE ALL DISTURBED AREAS WITHIN 14 DAYS OF COMPLETION. NOTIFY ALL LOCAL RESIDENTS 48 HOURS PRIOR TO START.

Approved By: A. Diaz Date: 03/07/23

- CONSTRUCTION NOTES:**
- ALL EXISTING UTILITIES CROSSED DURING THIS INSTALLATION WILL BE POTHOLED (CORE & VAC) TO EXPOSE TO WATCH AND PROTECT AND ALLOW PROPER CLEARANCE BETWEEN THE PROPOSED PIPE AND THE EXISTING UTILITY.
  - CALL J.U.L.I.E. - 800.892.0123

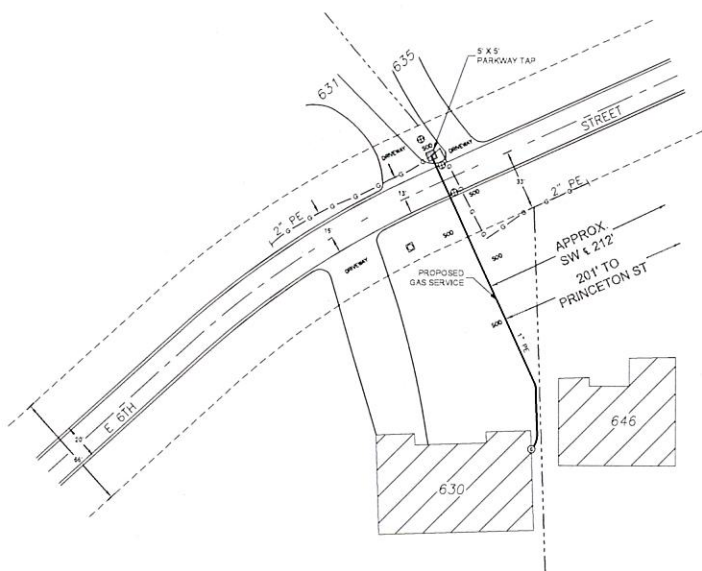

<b>ESPO ENGINEERING</b> <small>INCORPORATED IN ILLINOIS</small> <small>100 NORTH W. WASHINGTON ST. SUITE 200</small>		<b>630 E 6TH ST</b> TOWN: HINSDALE COUNTY: COOK		<b>Nicor Gas</b> <b>ISSUED FOR PERMITTING</b>		<b>LEGEND</b>	
DRAWN BY: MARK DATE: 02/29/23 <small>THIS DRAWING IS THE PROPERTY OF ESPO ENGINEERING. IT IS TO BE USED ONLY FOR THE PROJECT AND SITE SPECIFICALLY IDENTIFIED HEREIN. NO PART OF THIS DRAWING IS TO BE REPRODUCED OR TRANSMITTED IN ANY FORM OR BY ANY MEANS, WITHOUT THE WRITTEN PERMISSION FROM ESPO ENGINEERING.</small>	ENG NUMBER: NCP-23-0433 PROJECT: 3012E073 JOB#: 5596575 DSC#: 2157269	TOWNSHIP: LYONS SECTION: 3012E073 SCALE: 1"=50' SHEET: 1 OF 1	ALTAIR: WC2071C DATE: . PER: . DESIGNER: .	<b>LINES</b> GAS SERVICE LINE GAS METER GAS VALVE GAS MAIN GAS SERVICE LINE GAS METER GAS VALVE GAS MAIN UTILITY FACILITY WATER MAIN WATER SERVICE MAIN STORM SEWER MAIN STORM SEWER UNARMED ELECTRICAL CABLE	<b>SYMBOLS</b> GAS VALVE GAS METER GAS SERVICE TAP UNARMED MANHOLE CATCH BASIN		